


**Katrina
Lohr**



**Kitchen & Bath Planning
304-117, 2024**

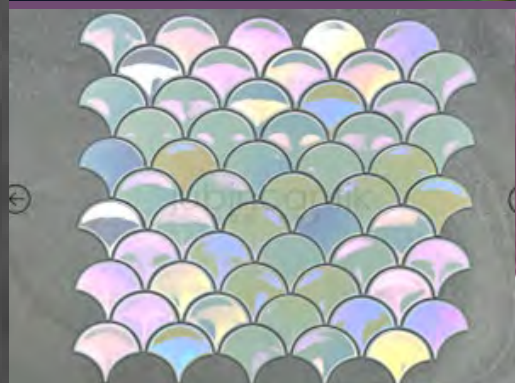

Ibiza, Spain

- Sheet Index
- Page 1- Cover Page
- Page 2- Floor Plan
- Page 3- Electrical Plan
- Page 4- Electrical Legend
- Page 5-8- Elevations

**ADA
HOTEL
SUITE**

**Cover
Page**



Katrina Lohr


Client
Address
Phone
Email

ADA HOTEL REMODEL KB PLANNING

Scale: 1/2" = 1'-0"

BATH FLOOR PLAN

A-100

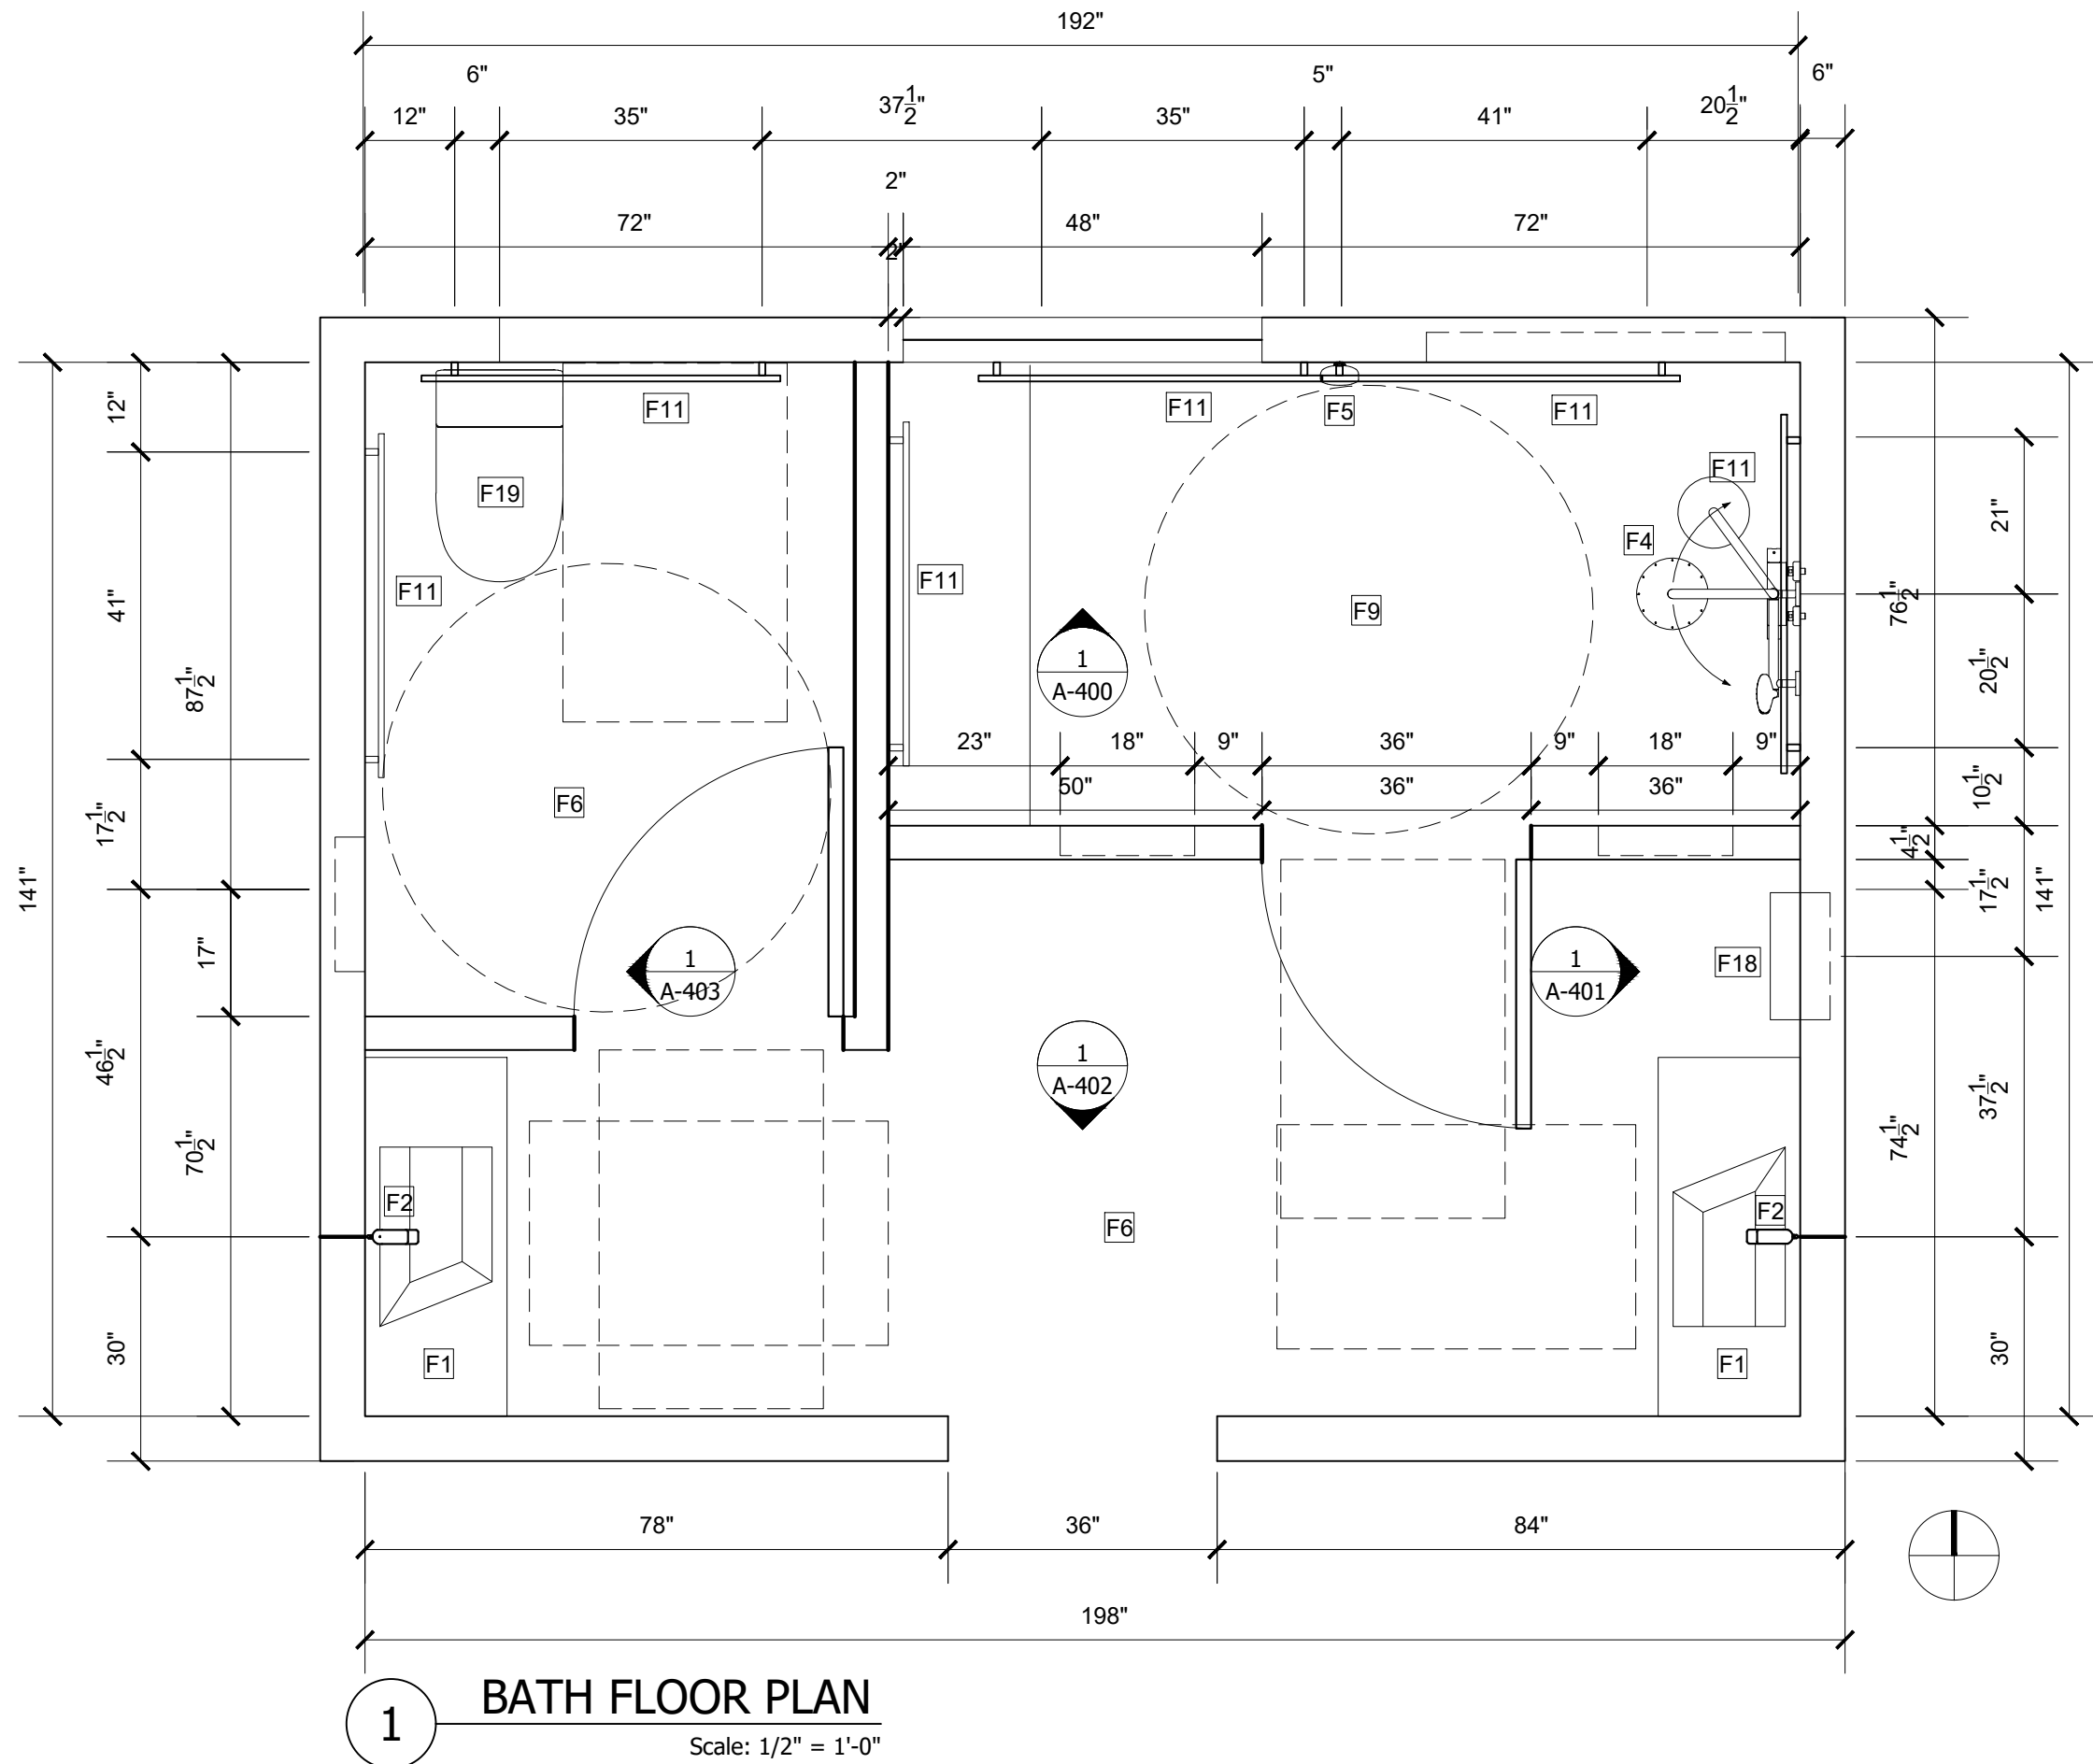

1 BATH FLOOR PLAN
Scale: 1/2" = 1'-0"



Katrina Lohr


Client
Address
Phone
Email

ADA HOTEL REMODEL KB PLANNING

Scale: 1/2" = 1'-0"

ELECTRIC PLAN

E-400

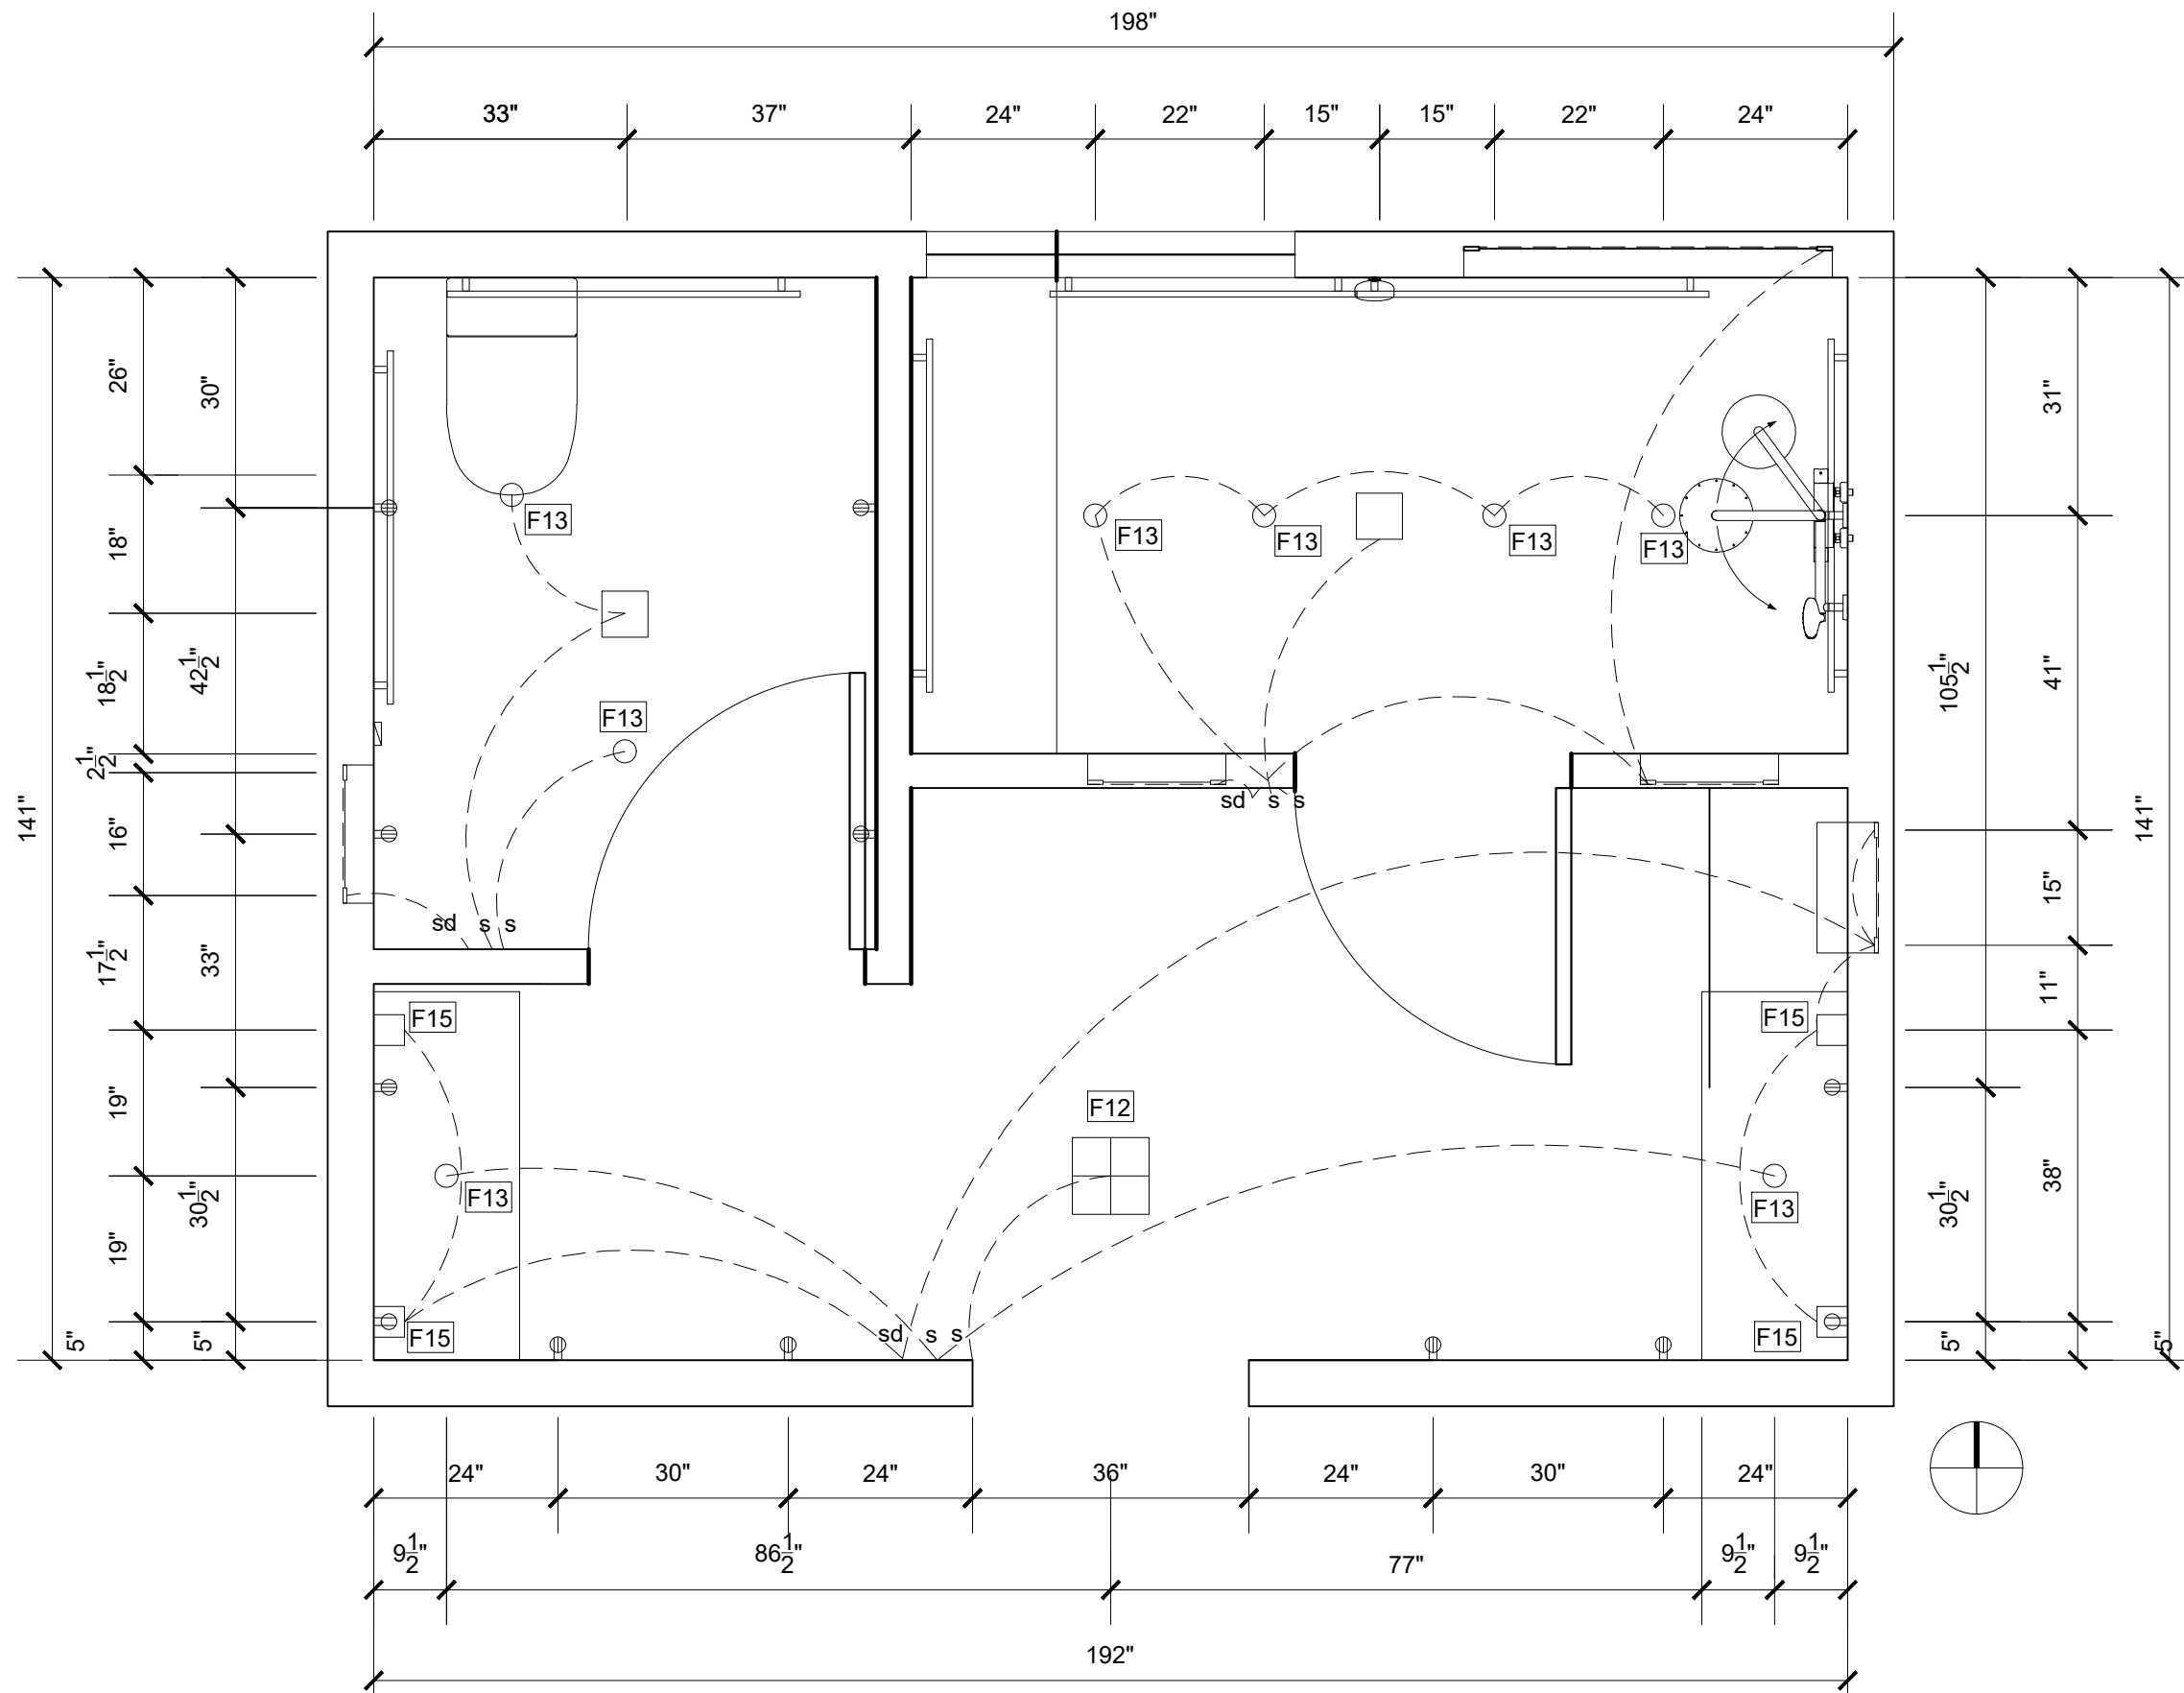

1 **ELECTRICAL PLAN**
Scale: 1/2" = 1'-0"



Katrina Lohr

Client
Address
Phone
Email

ADA HOTEL
REMODEL
KB PLANNING

Scale: NTS

ELECTRIC
PLAN

E-401

ELECTRICAL LEGEND				
SYMBOL	TYPE	HEIGHT	MANUFACTURER	MODEL NUMBER
	RECEPTACLE 18" AFF	18" AFF	LEGEND RADIANT	RAD540923
	RECEPTACLE 42" AFF	42" AFF	LEGEND RADIANT	RAD540923
	SCONCE	52" AFF TO BASE OF SCONE	LITFAD	229717071
	FLUSH MOUNT	TOP OF LIGHT AT CEILING	LAS SOLA	MORANDI
	RECESSED LIGHT	AT CEILING	WAC LIGHTING	LOTOS
	LED LIGHT STRIP	UNDERNEATH EVERY SHELVES OF CUBBIES	WAC LIGHTING	T24-DD1-01-27
s	SINGLE POLE	42" AFF	HANSEL AND GRETTEL	Modern Luxury Wall Switch Panel
	VENT	AT CEILING	HOMEWERKS	80 CFM 1.1 Sone Bathroom Ventilation
sd	DIMMER	42" AFF	ADORNE	SOFTAP
	AUTOMATIC DOOR OPENER	33 1/2" AFF	VISIONIS	VIS-8015

1 ELECTRICAL PLAN LEGEND
Scale: NTS



Katrina Lohr


Client
Address
Phone
Email

ADA HOTEL REMODEL KB PLANNING

Scale: 1/2" = 1'-0"

ELEV.

A-400

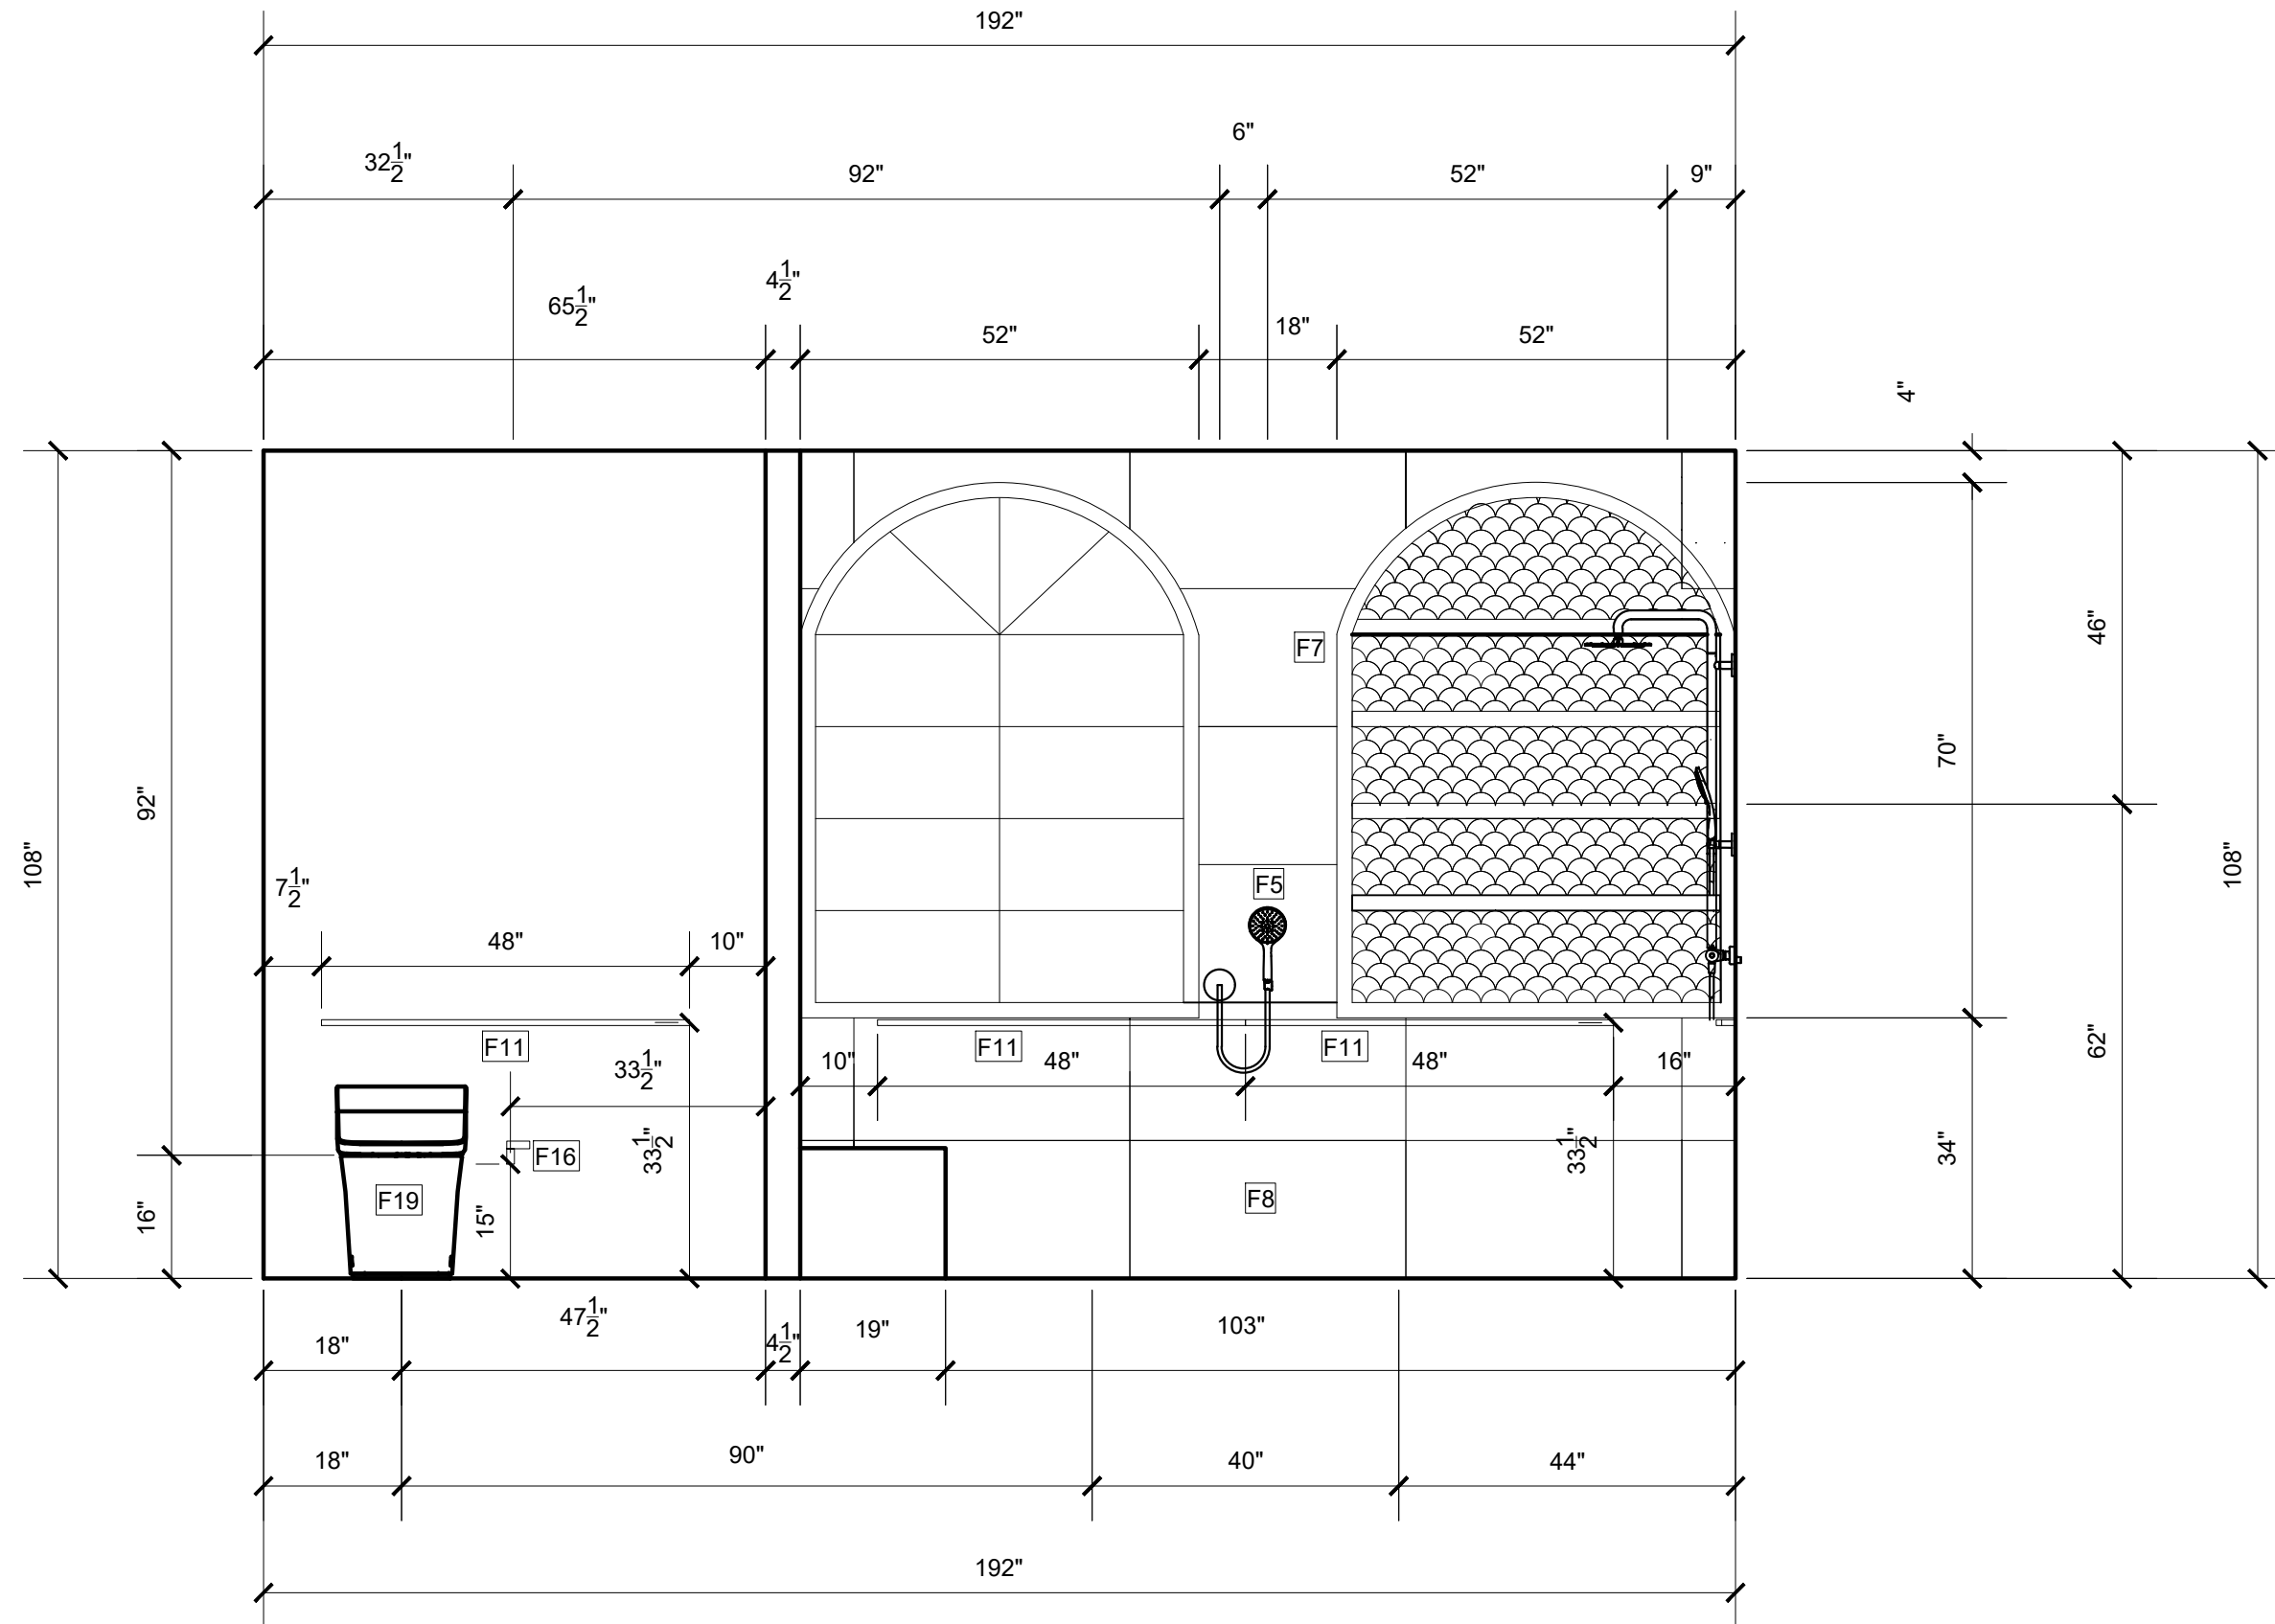

1 ADA SUITE NORTH WALL ELEVATION
Scale: 1/2" = 1'-0"



Katrina Lohr


Client
Address
Phone
Email

ADA HOTEL
REMODEL
KB PLANNING

Scale: 1/2" = 1'-0"

ELEV.

A-401

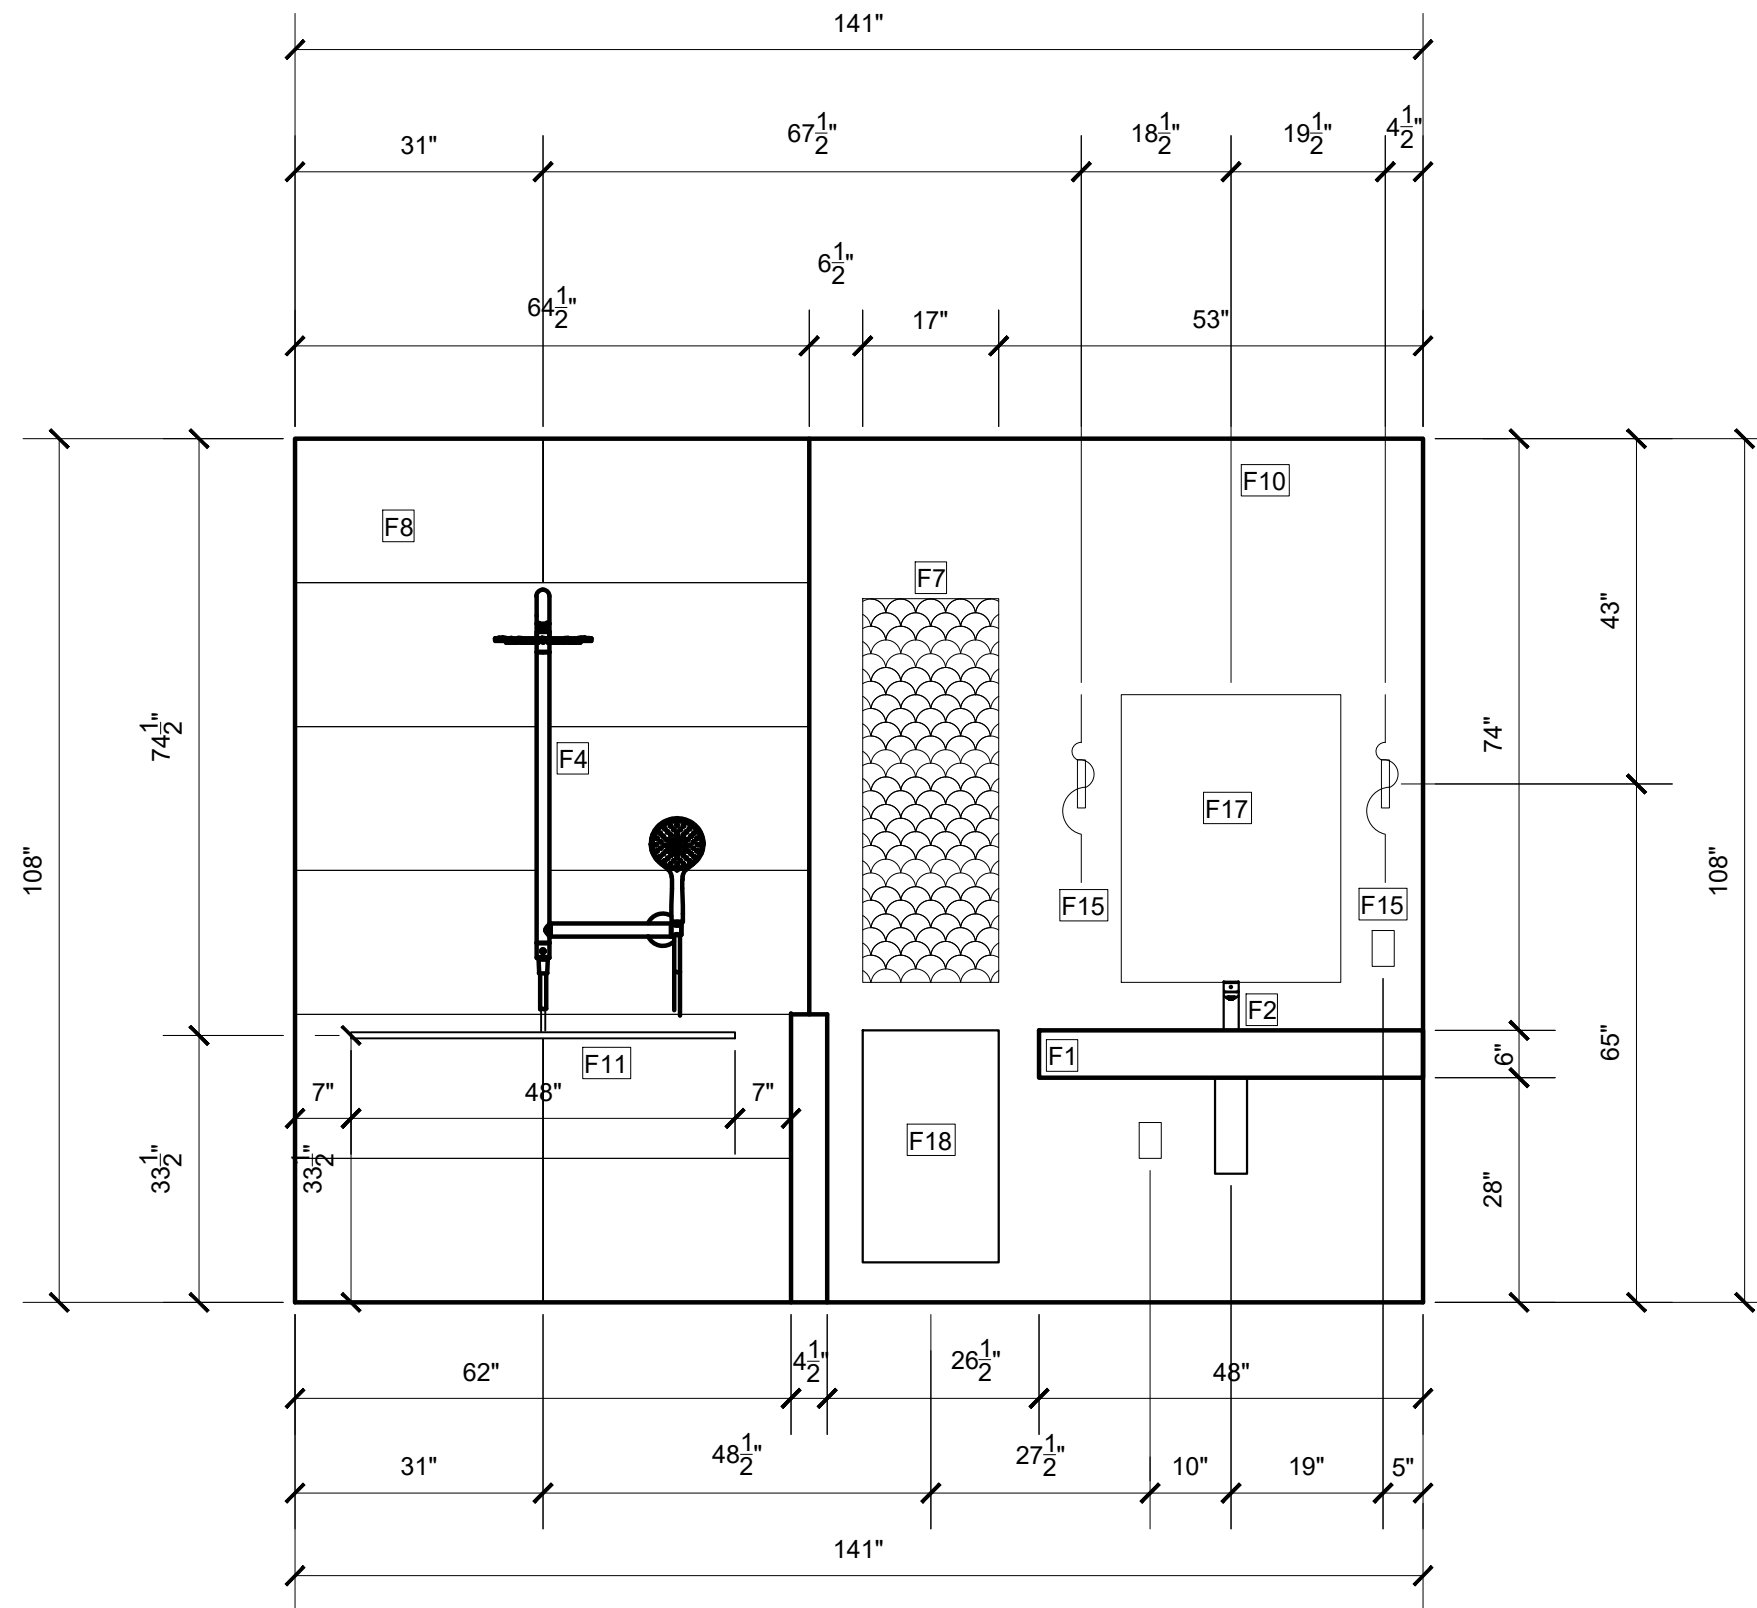

1

ADA SUITE EAST WALL ELEVATION

Scale: 1/2" = 1'-0"



Katrina Lohr


Client
Address
Phone
Email

ADA HOTEL
REMODEL
KB PLANNING

Scale: 1/2" = 1'-0"

ELEV.

A-402

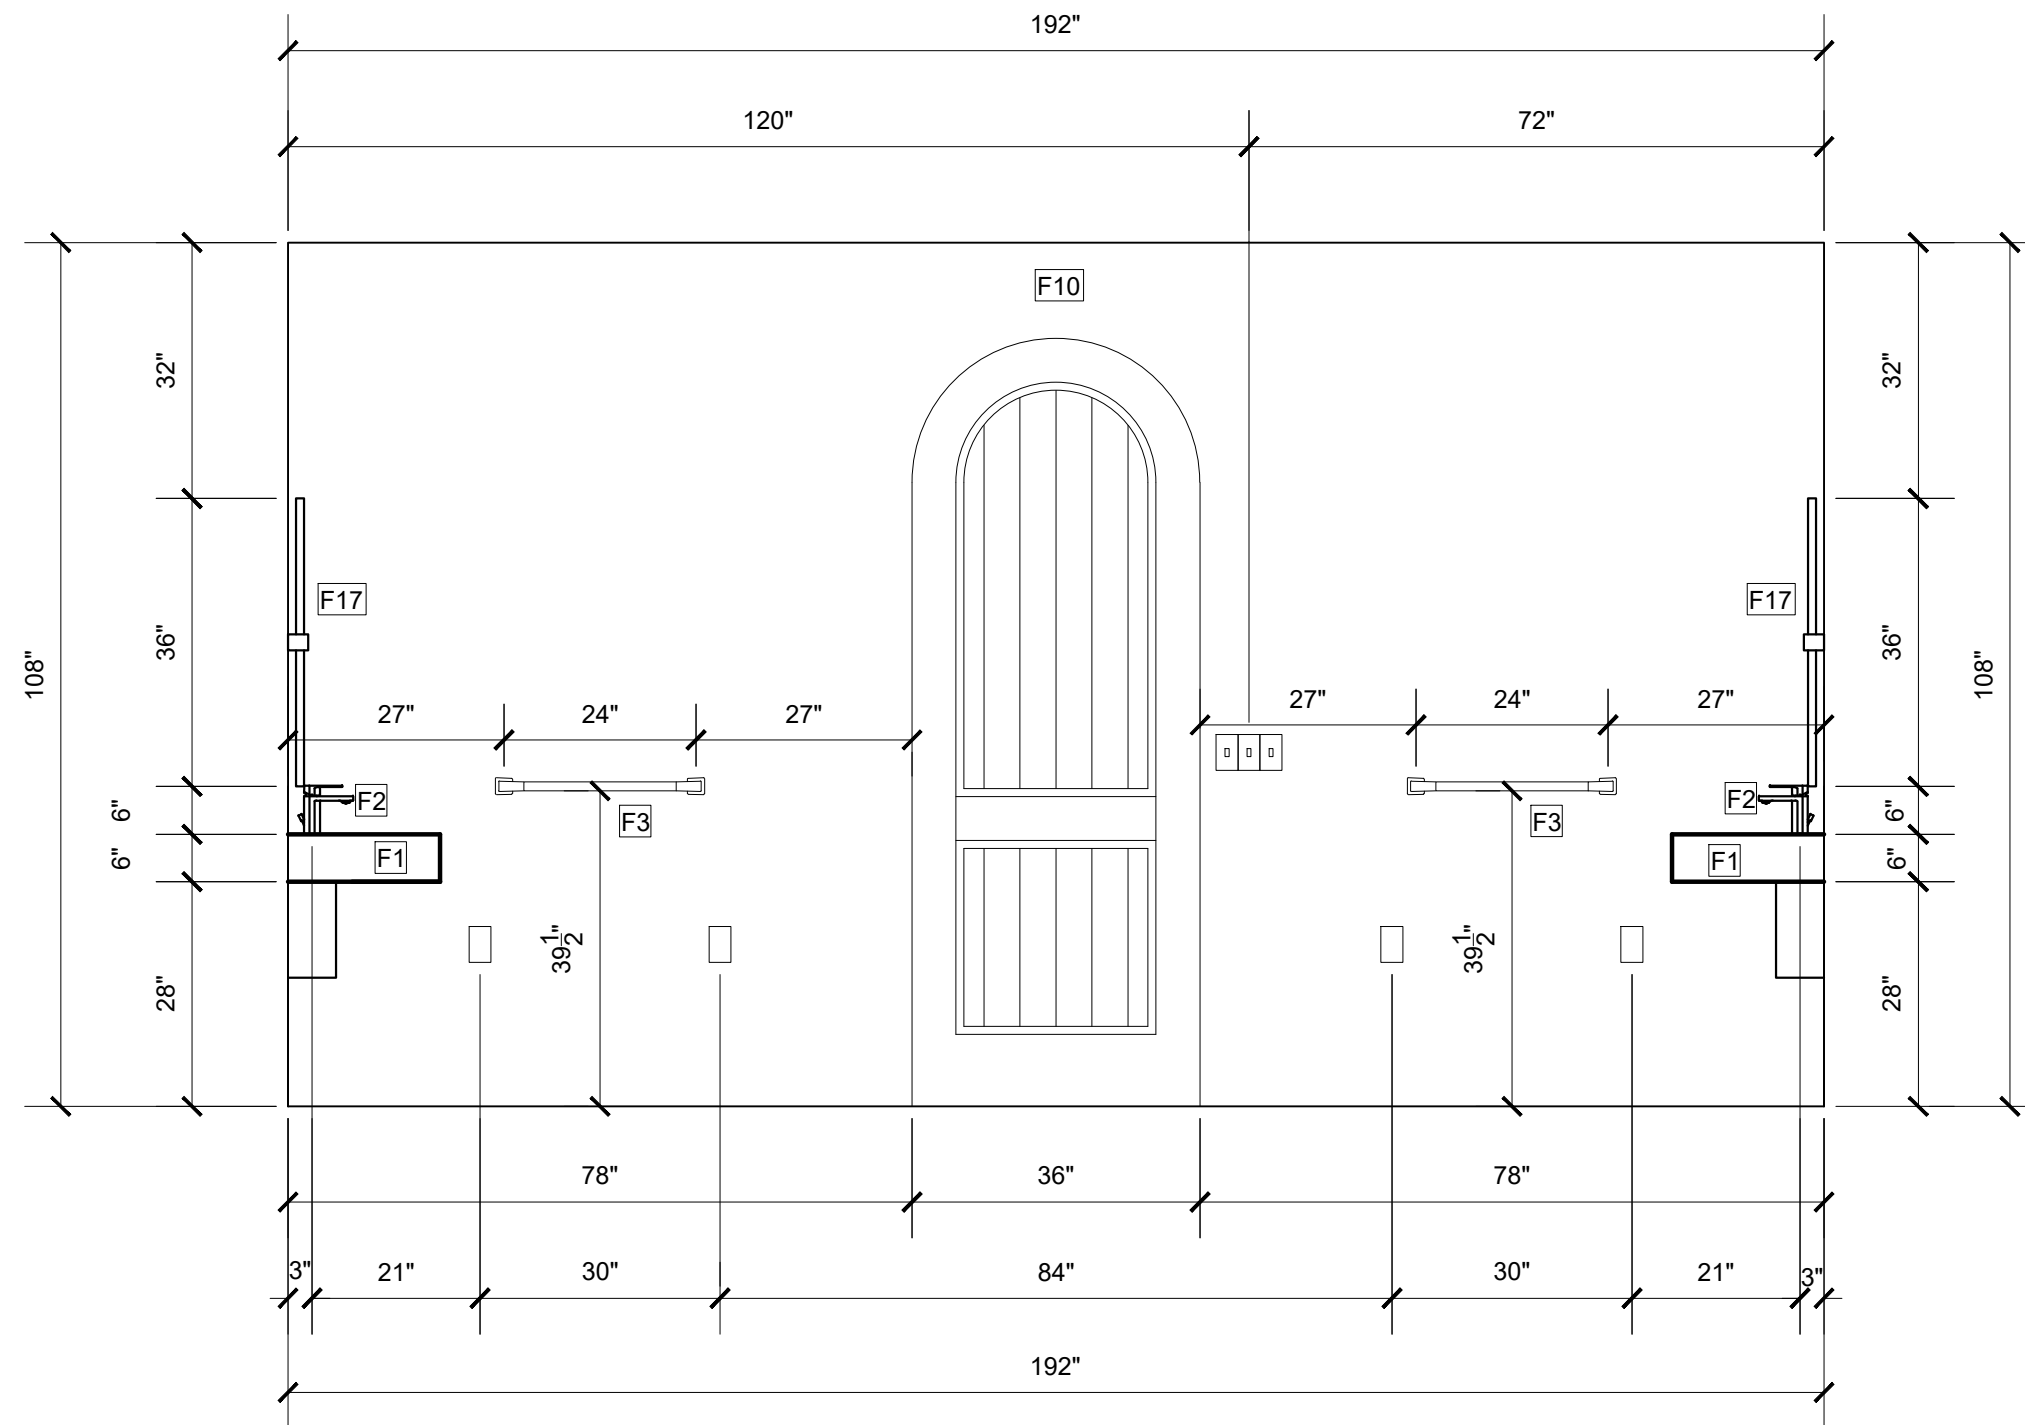

1 ADA SUITE SOUTH WALL ELEVATION
Scale: 1/2" = 1'-0"



Katrina Lohr


Client
Address
Phone
Email

ADA HOTEL REMODEL KB PLANNING

Scale: 1/2" = 1'-0"

ELEV.

A-403

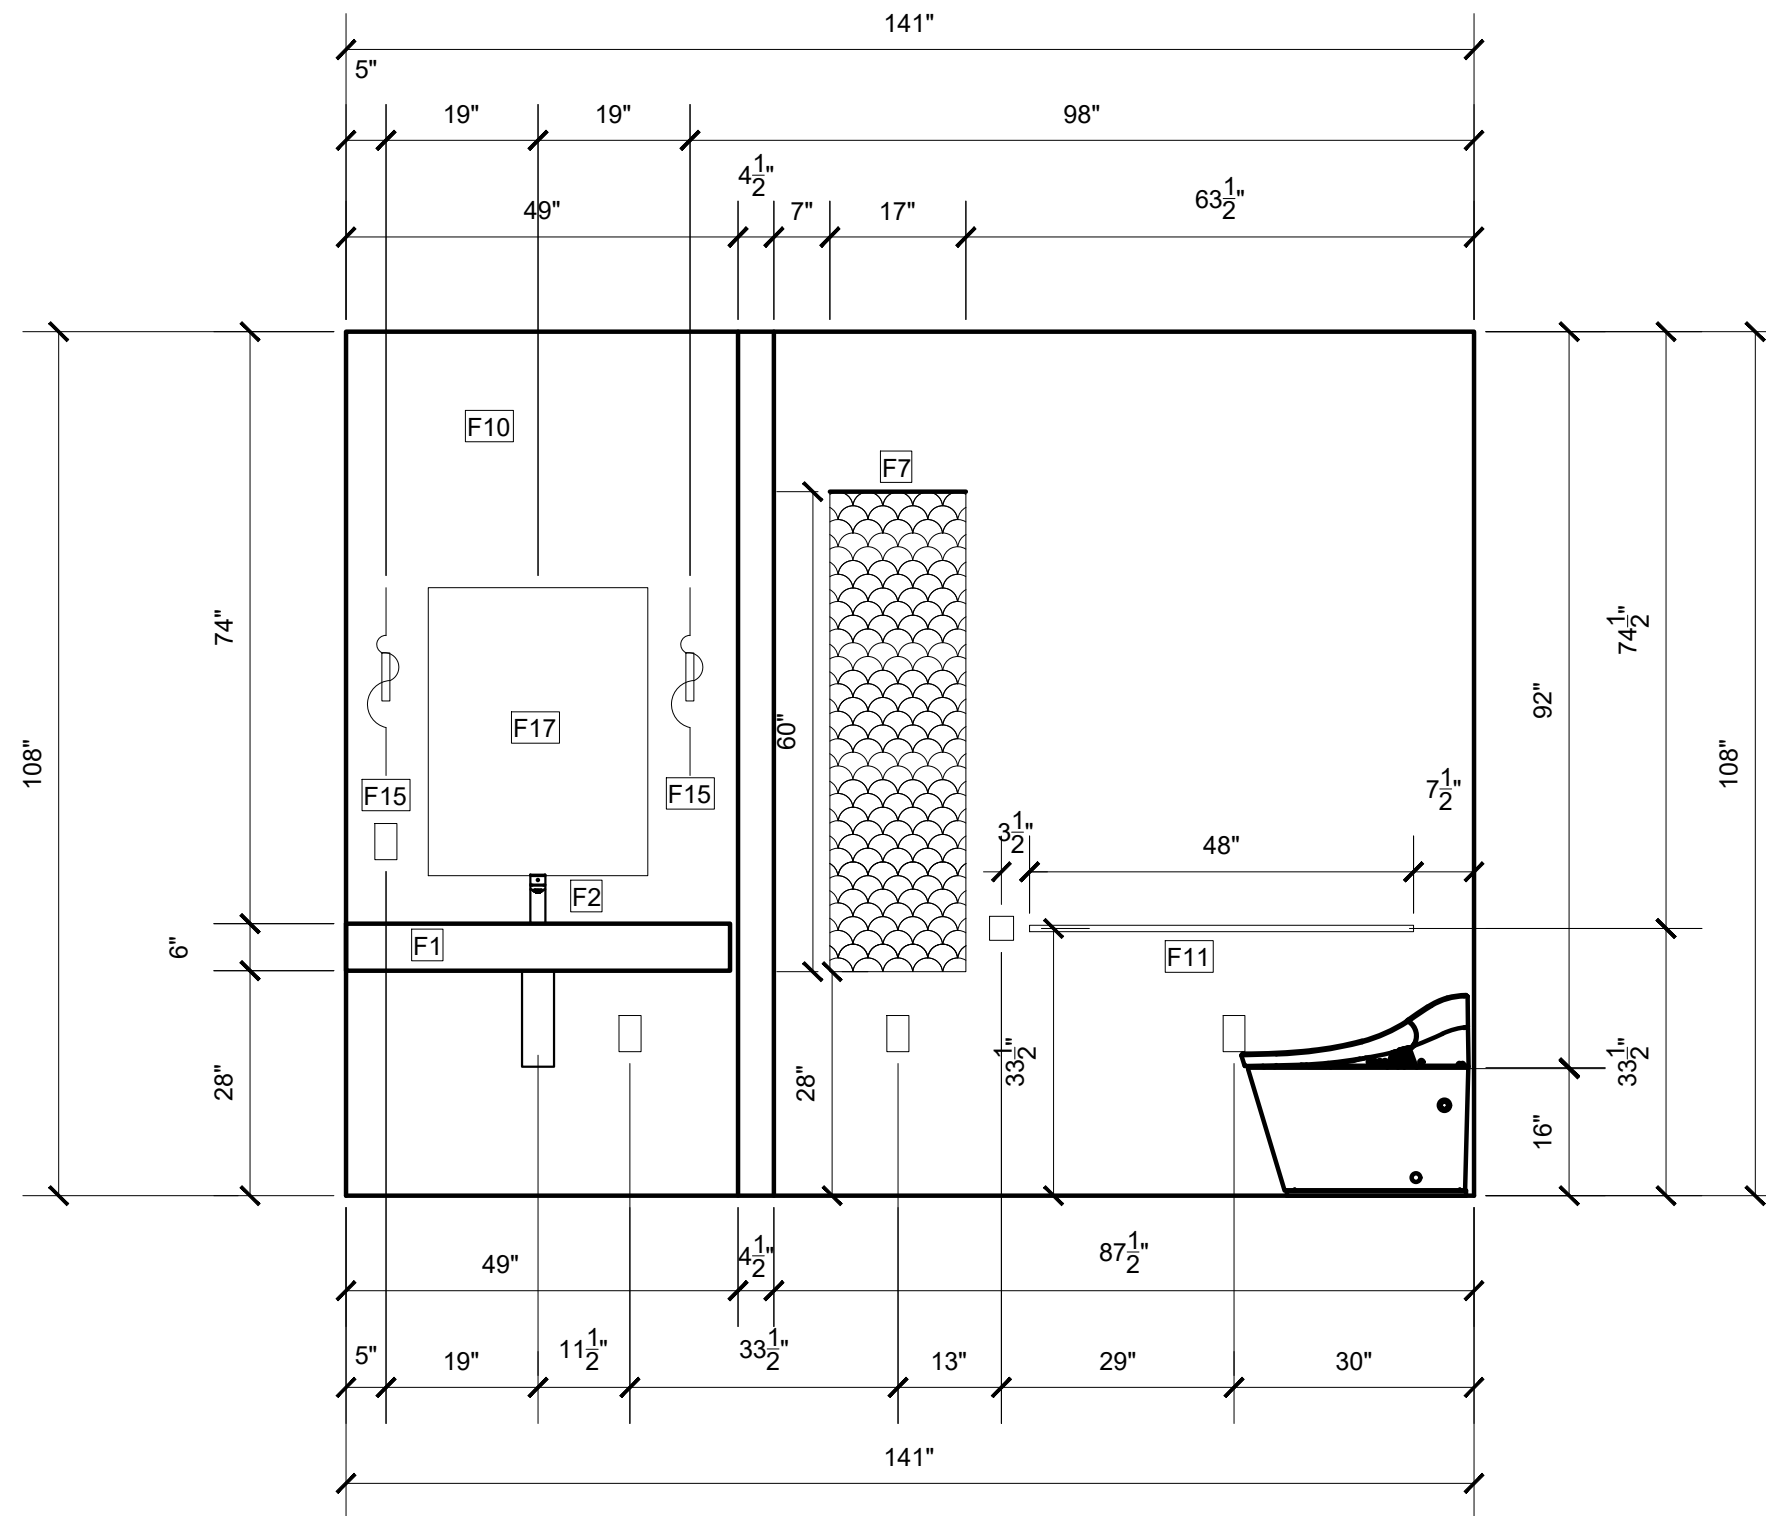

1 ADA SUITE WEST WALL ELEVATION
Scale: 1/2" = 1'-0"